
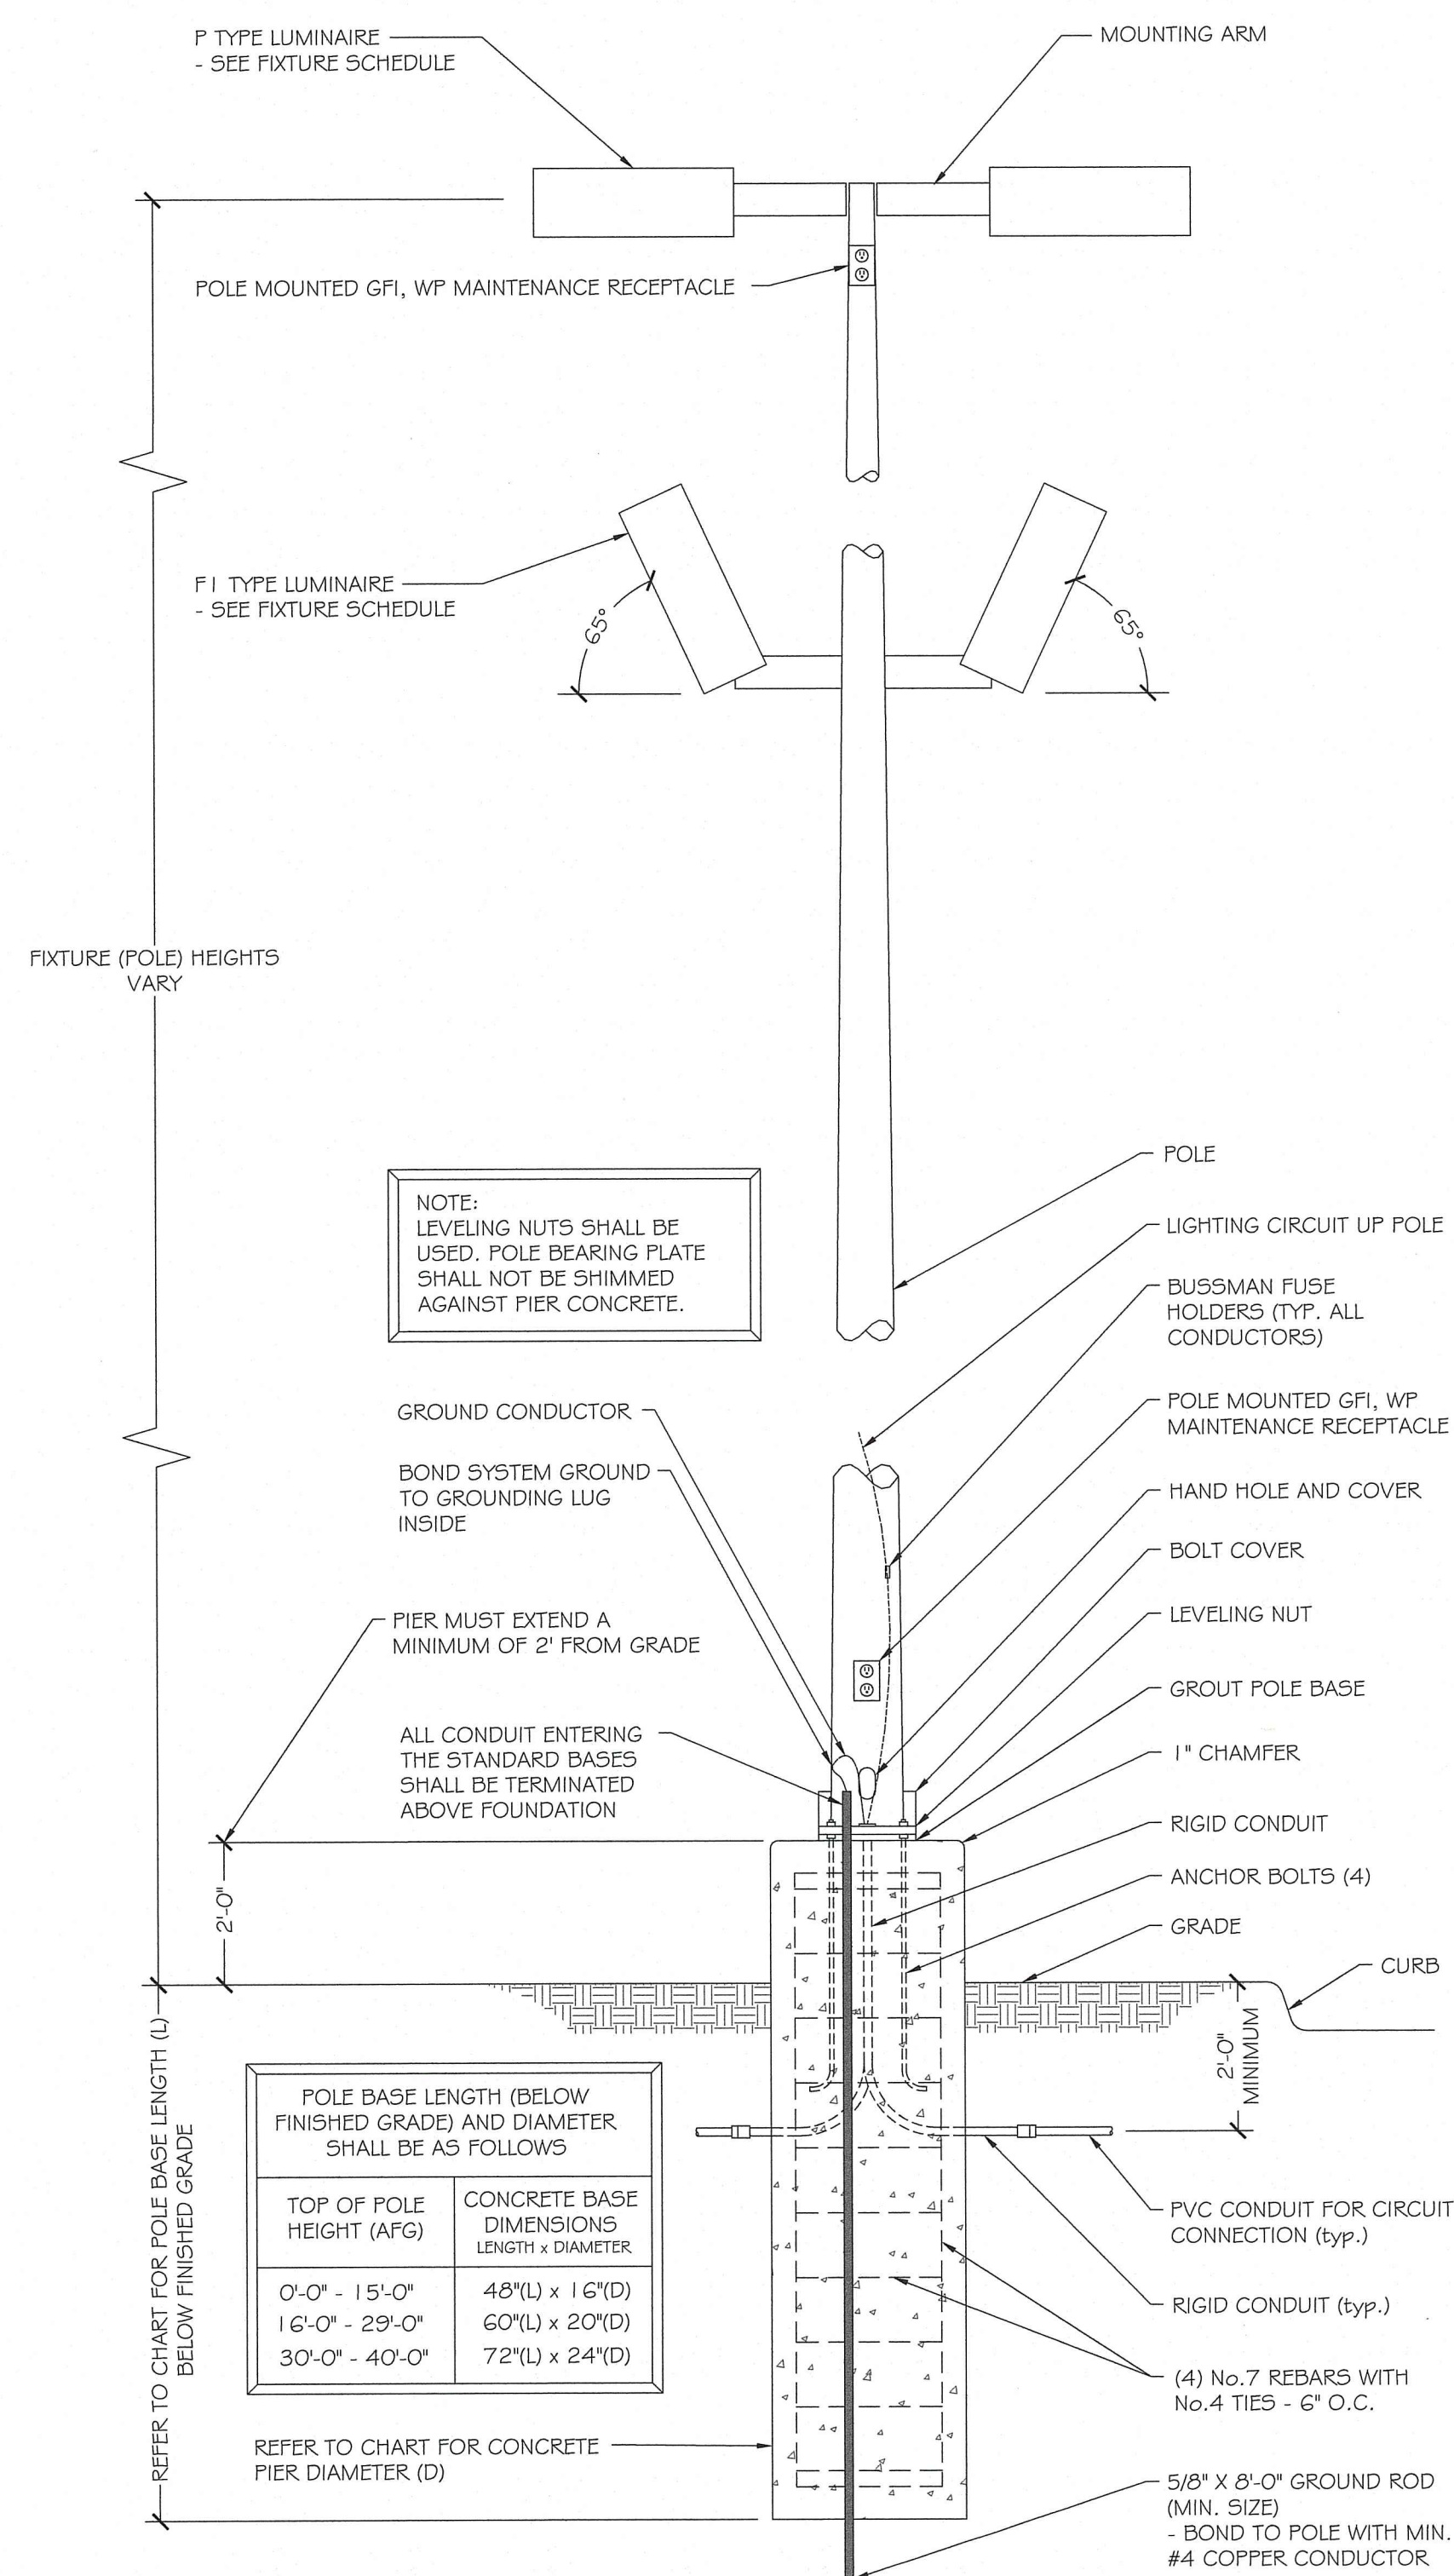






Luminaire Schedule										
Symbol	Qty	Arrangement	Fixture Type	Description	Manufacturer	Catalog Number	LLF	Total Watts	Delivered Lumens	Photometric File Name
	7	SINGLE	F1-4X4 EX	LED FLOODLIGHT, 4X4 BEAM, ANGLED 65 ABOVE NADIR	BEACON PRODUCTS	AL-X-72L-295-5K7-4X4-UNV_	0.900	297	27212	AL-X-72L-295-5K7-4X4-UNV.ies
	1	SINGLE	P4W-1@90 EX	AREA LIGHT, 1@90, TYPE IV DISTRIBUTION, 35' MOUNTING HEIGHT	LUMINOSO LED LIGHTING	GLZ 500W 4M - 1@90_	0.900	500	72528	GLZ 500W 4M.IES
	2	2 @ 90 DEGREES	P4W-2@90 EX	AREA LIGHT, 2@90 TYPE IV DISTRIBUTION, 35' MOUNTING HEIGHT	LUMINOSO LED LIGHTING	GLZ 500W 4M - 2@90_	0.900	1000	145056	GLZ 500W 4M.IES
	1	SINGLE	P4WA-1@90 EX	AREA LIGHT, 1@90, TYPE IV DISTRIBUTION, 38' MOUNTING HEIGHT	LUMINOSO LED LIGHTING	GLZ 500W 4M - 1@90 - 38'	0.900	500	72528	GLZ 500W 4M.IES
	3	SINGLE	P5-1@90 EX	AREA LIGHT, 1@90 TYPE V DISTRIBUTION, 30' MOUNTING HEIGHT	LUMINOSO LED LIGHTING	GLZ 300W 5M - 1 @90_	0.900	303.8	43274	GLZ 300W 5M.IES
	4	4 @ 90 DEGREES	P5-4@90 EX	AREA LIGHT, 4@90, TYPE V DISTRIBUTION, 35' MOUNTING HEIGHT	LUMINOSO LED LIGHTING	GLZ 500W 5M - 4@90_	0.900	2000	281844	GLZ 500W 5M.IES
	3	SINGLE	R2 EX	CANOPY LIGHT	LUMINOSO LED INC	ECPPY-14-65W-50K-W-Y-X	0.900	64.9	6320	ECPPY-65W-50K-.IES.ies
	7	SINGLE	W1 EX	WALL PACK	Luminoso Led Lighting Inc	MWPCK-17W-40K	0.900	17.4	1688	MWPCK-17W-40K.IES
	1	SINGLE	V4 EX	AREA LIGHT, 1@90 TYPE V DISTRIBUTION, MOUNTED 16" TO BUILDING	LUMINOSO LED LIGHTING	GLZ 300W 4M - WALL	0.900	298.2	42256	GLZ 300W 4M.IES
	12	SINGLE	F1-M	LED FLOODLIGHT, MEDIUM FLOOD 4X4 BEAM, ANGLED 65 ABOVE NADIR	HUBBELL OUTDOOR	RFL5-360L-265-5K7-M	0.900	252	28288	RFL5-360L-265-5K7-M.ies
	3	SINGLE	P3-1@90	AREA LIGHT, 1@90 TYPE III DISTRIBUTION, 35' MOUNTING HEIGHT	LUMINOSO LED LIGHTING	GLZ2 500W 3M - 1@90	0.900	504.4	71708	GLZ 500W 3M.IES
	1	SINGLE	P4W-1@90	AREA LIGHT, 1@90, TYPE IV DISTRIBUTION, 35' MOUNTING HEIGHT	LUMINOSO LED LIGHTING	GLZ2 500W 4M - 1@90	0.900	500	72528	GLZ 500W 4M.IES
	2	2 @ 90 DEGREES	P4W-2@90	AREA LIGHT, 2@90 TYPE IV DISTRIBUTION, 35' MOUNTING HEIGHT	LUMINOSO LED LIGHTING	GLZ2 500W 4M - 2@90	0.900	1000	145056	GLZ 500W 4M.IES
	4	4 @ 90 DEGREES	P5-4@90	AREA LIGHT, 4@90, TYPE V DISTRIBUTION, 35' MOUNTING HEIGHT	LUMINOSO LED LIGHTING	GLZ2 500W 5M - 4@90	0.900	2000	281844	GLZ 500W 5M.IES

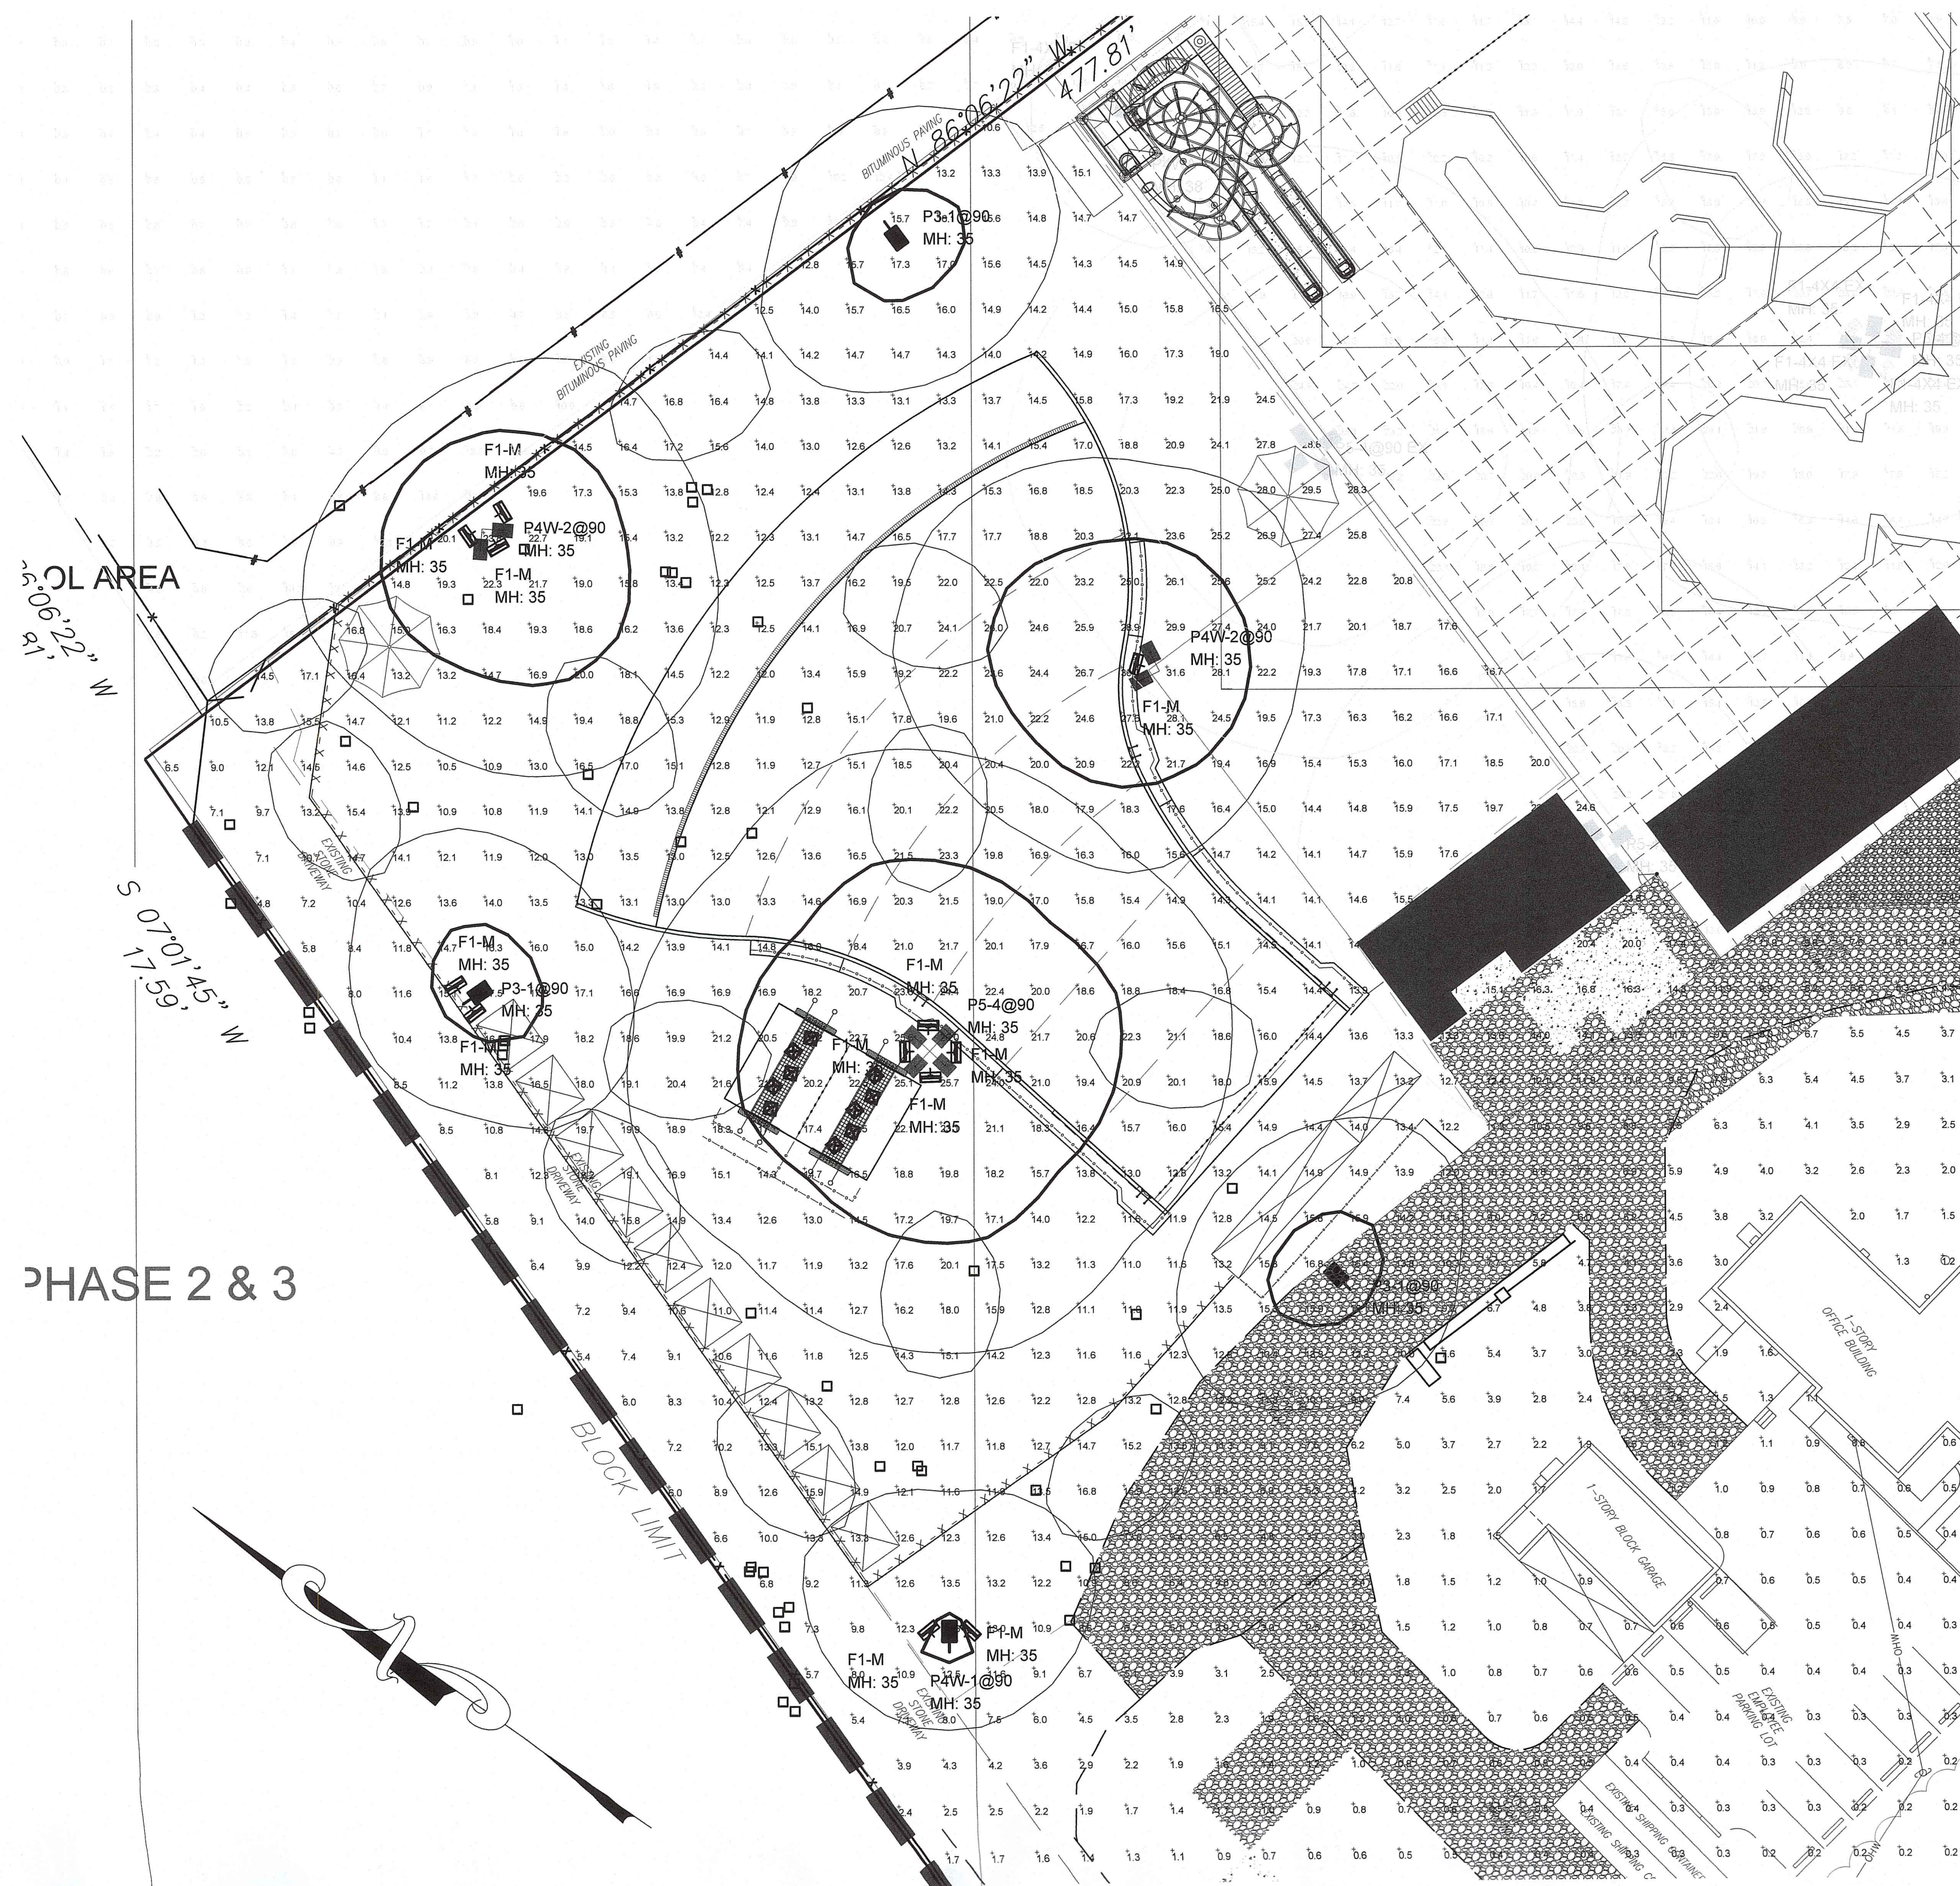

James E. Howard

MARK	DATE	DESCRIPTION
DATE ISSUED:	07/30/2021	
ISSUE PHASE:	REGULATORY SUBMITTAL	
PROJECT TITLE:		
DIGGERLAND USA PHASE II EXPANSION		
PROJECT OWNER:		
DIGGERLAND USA		
PROJECT LOCATION:		
441 EAST FRANKLIN AVE. WEST BERLIN, NJ 08091		
SHEET TITLE:		

PROJECT NUMBER	50726
SHEET NUMBER	1 P 1

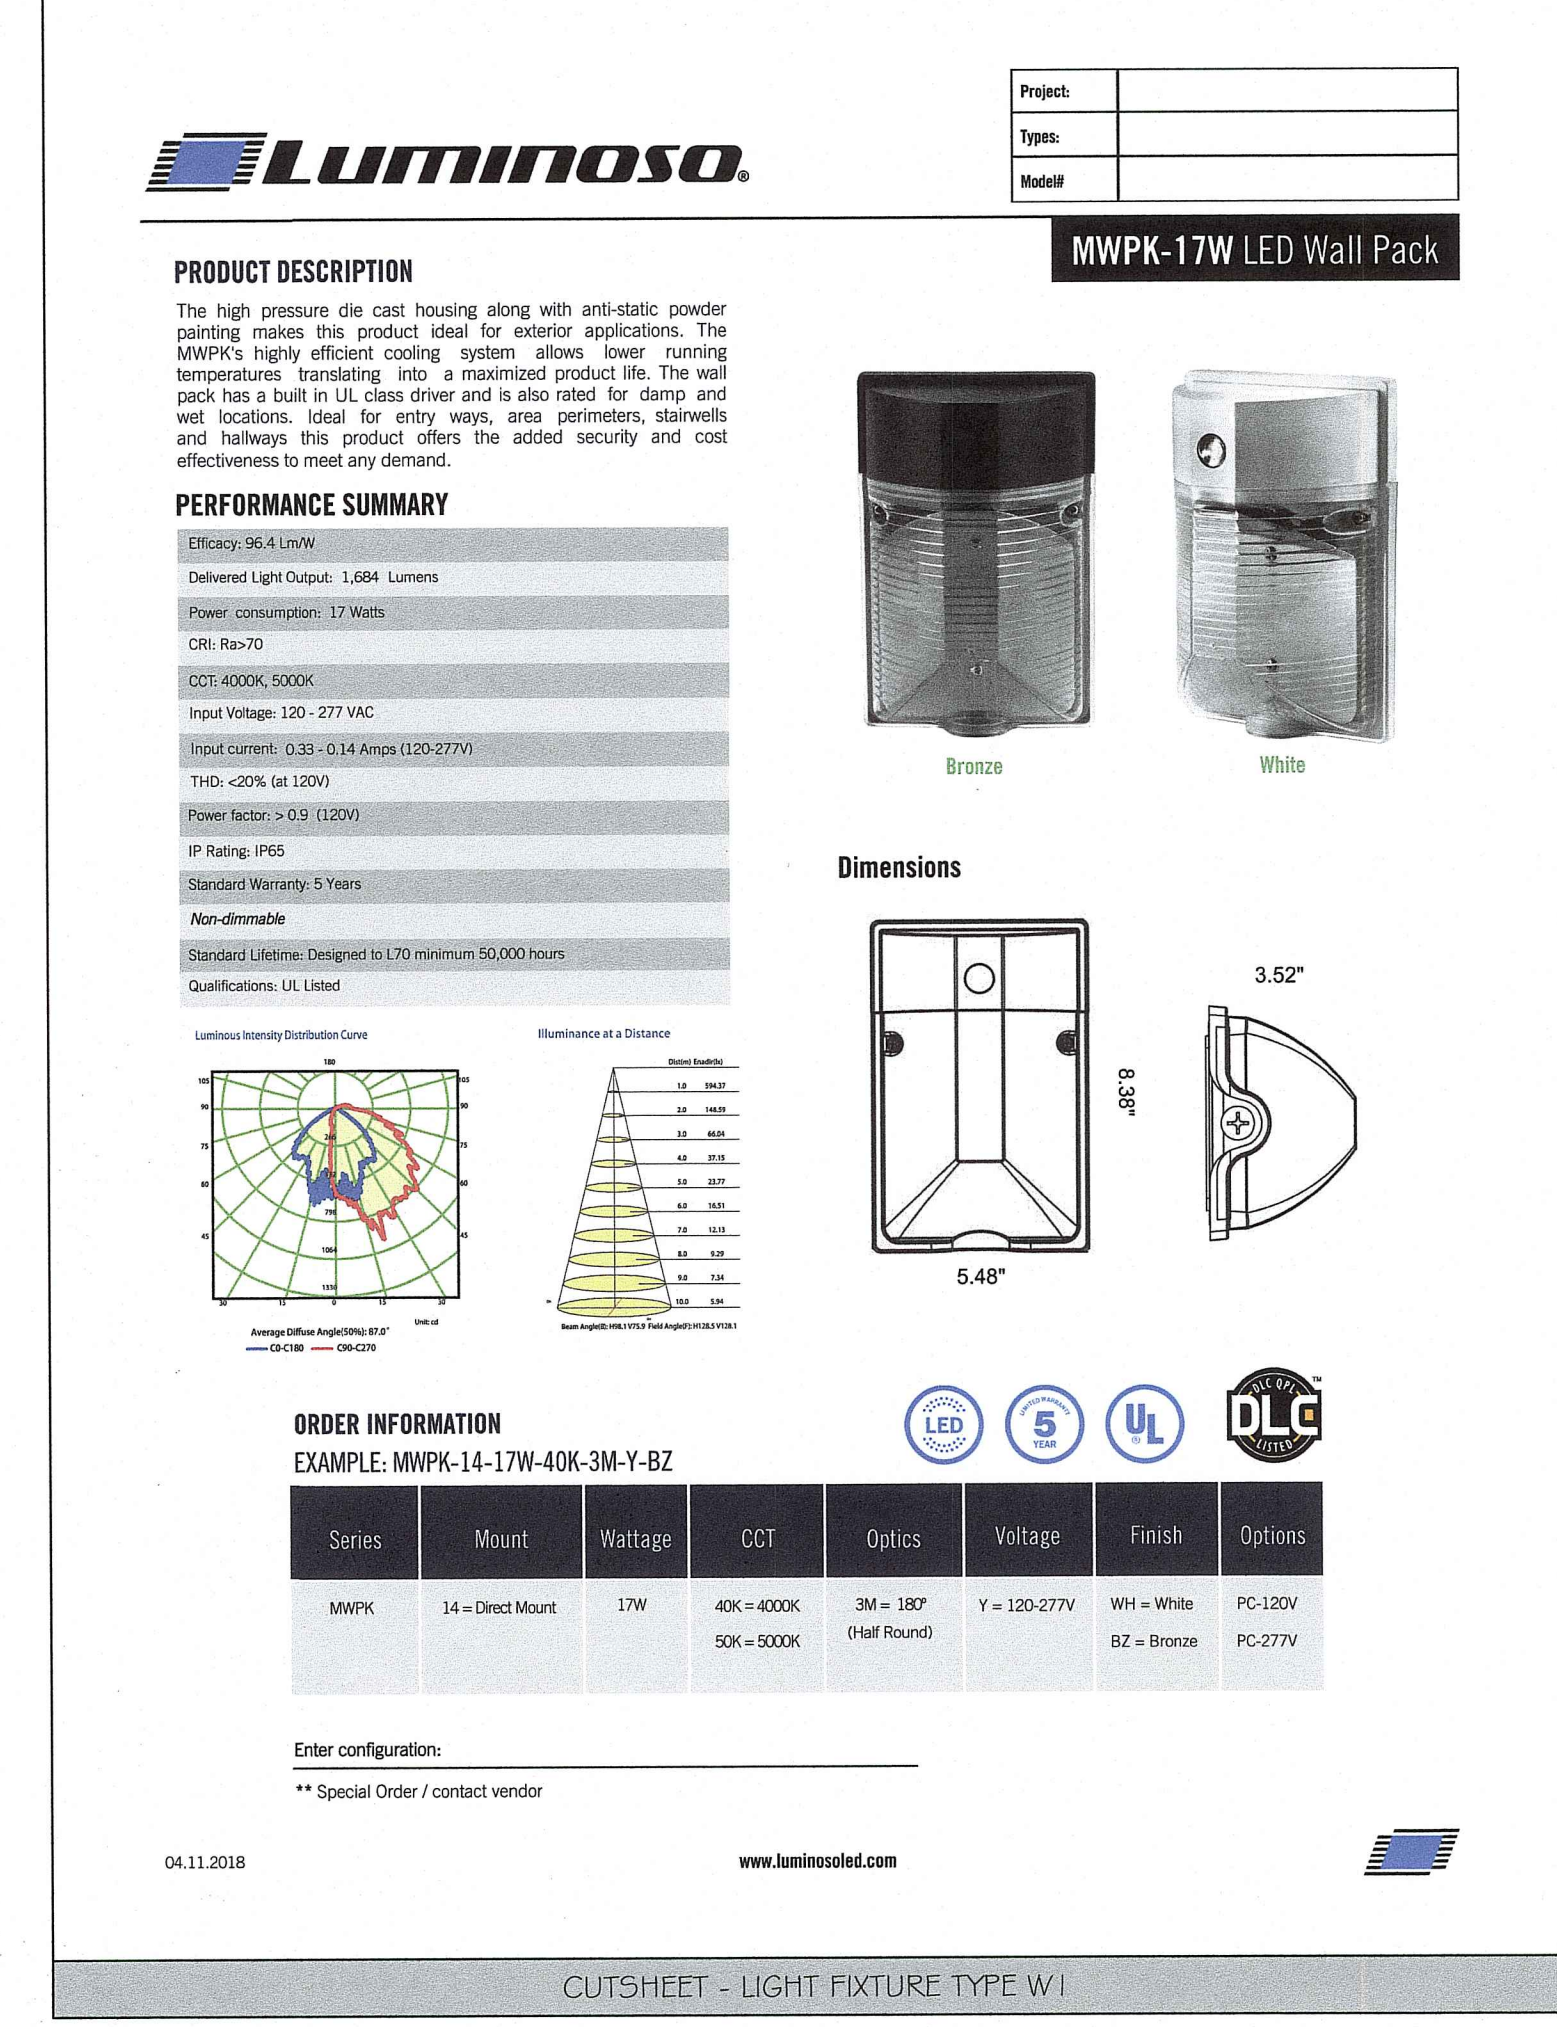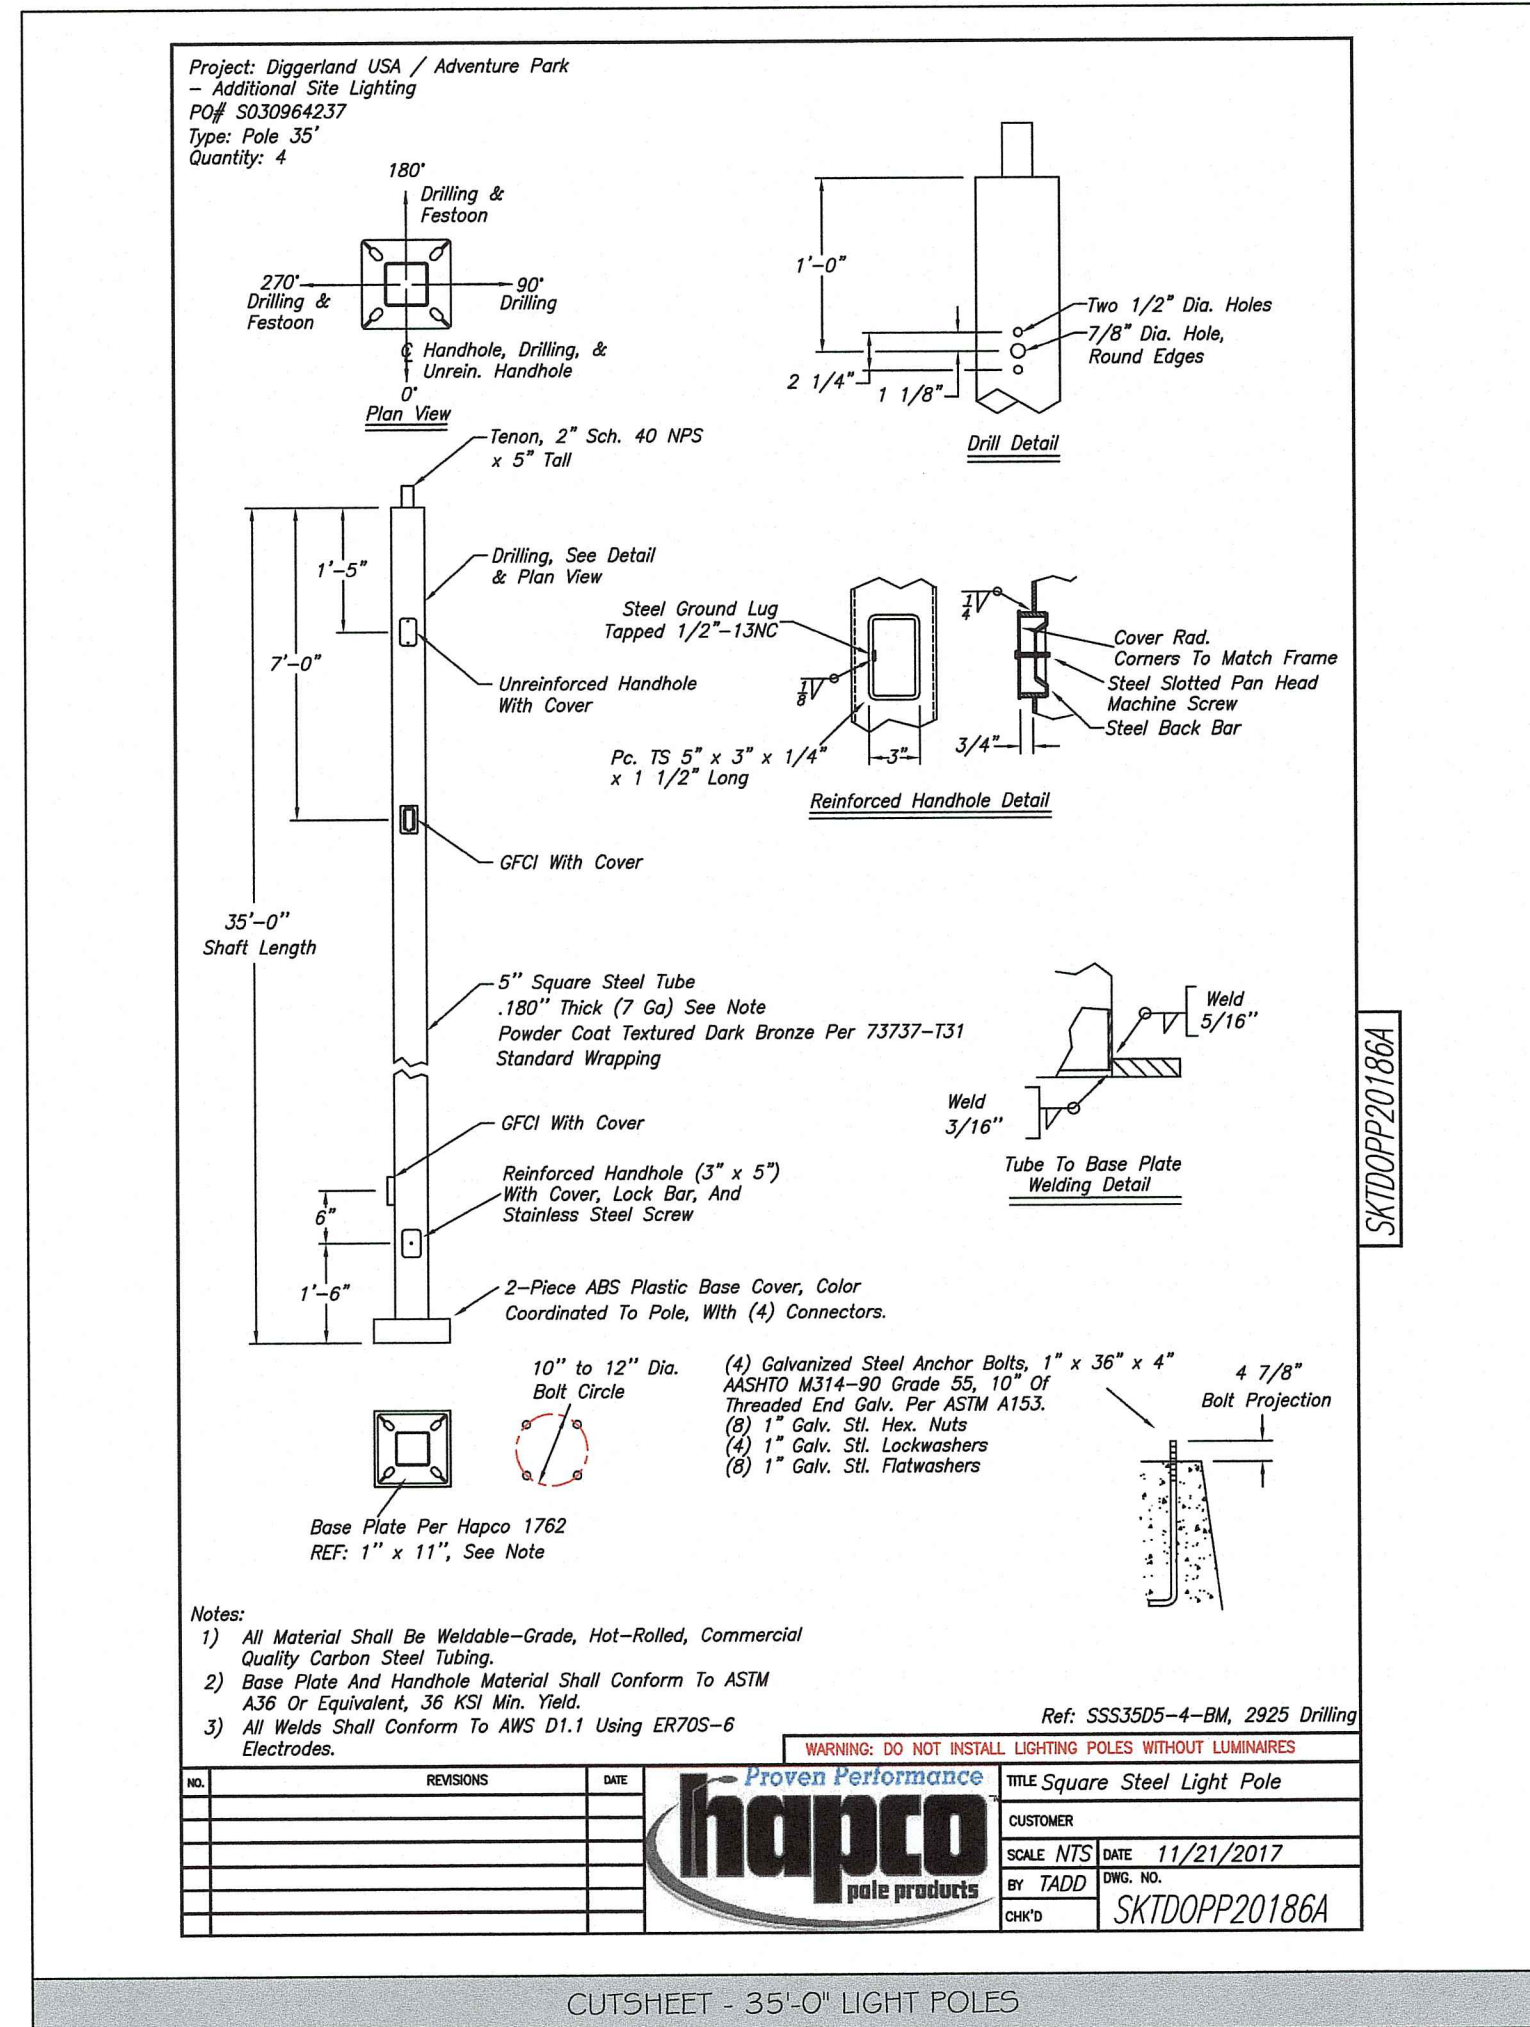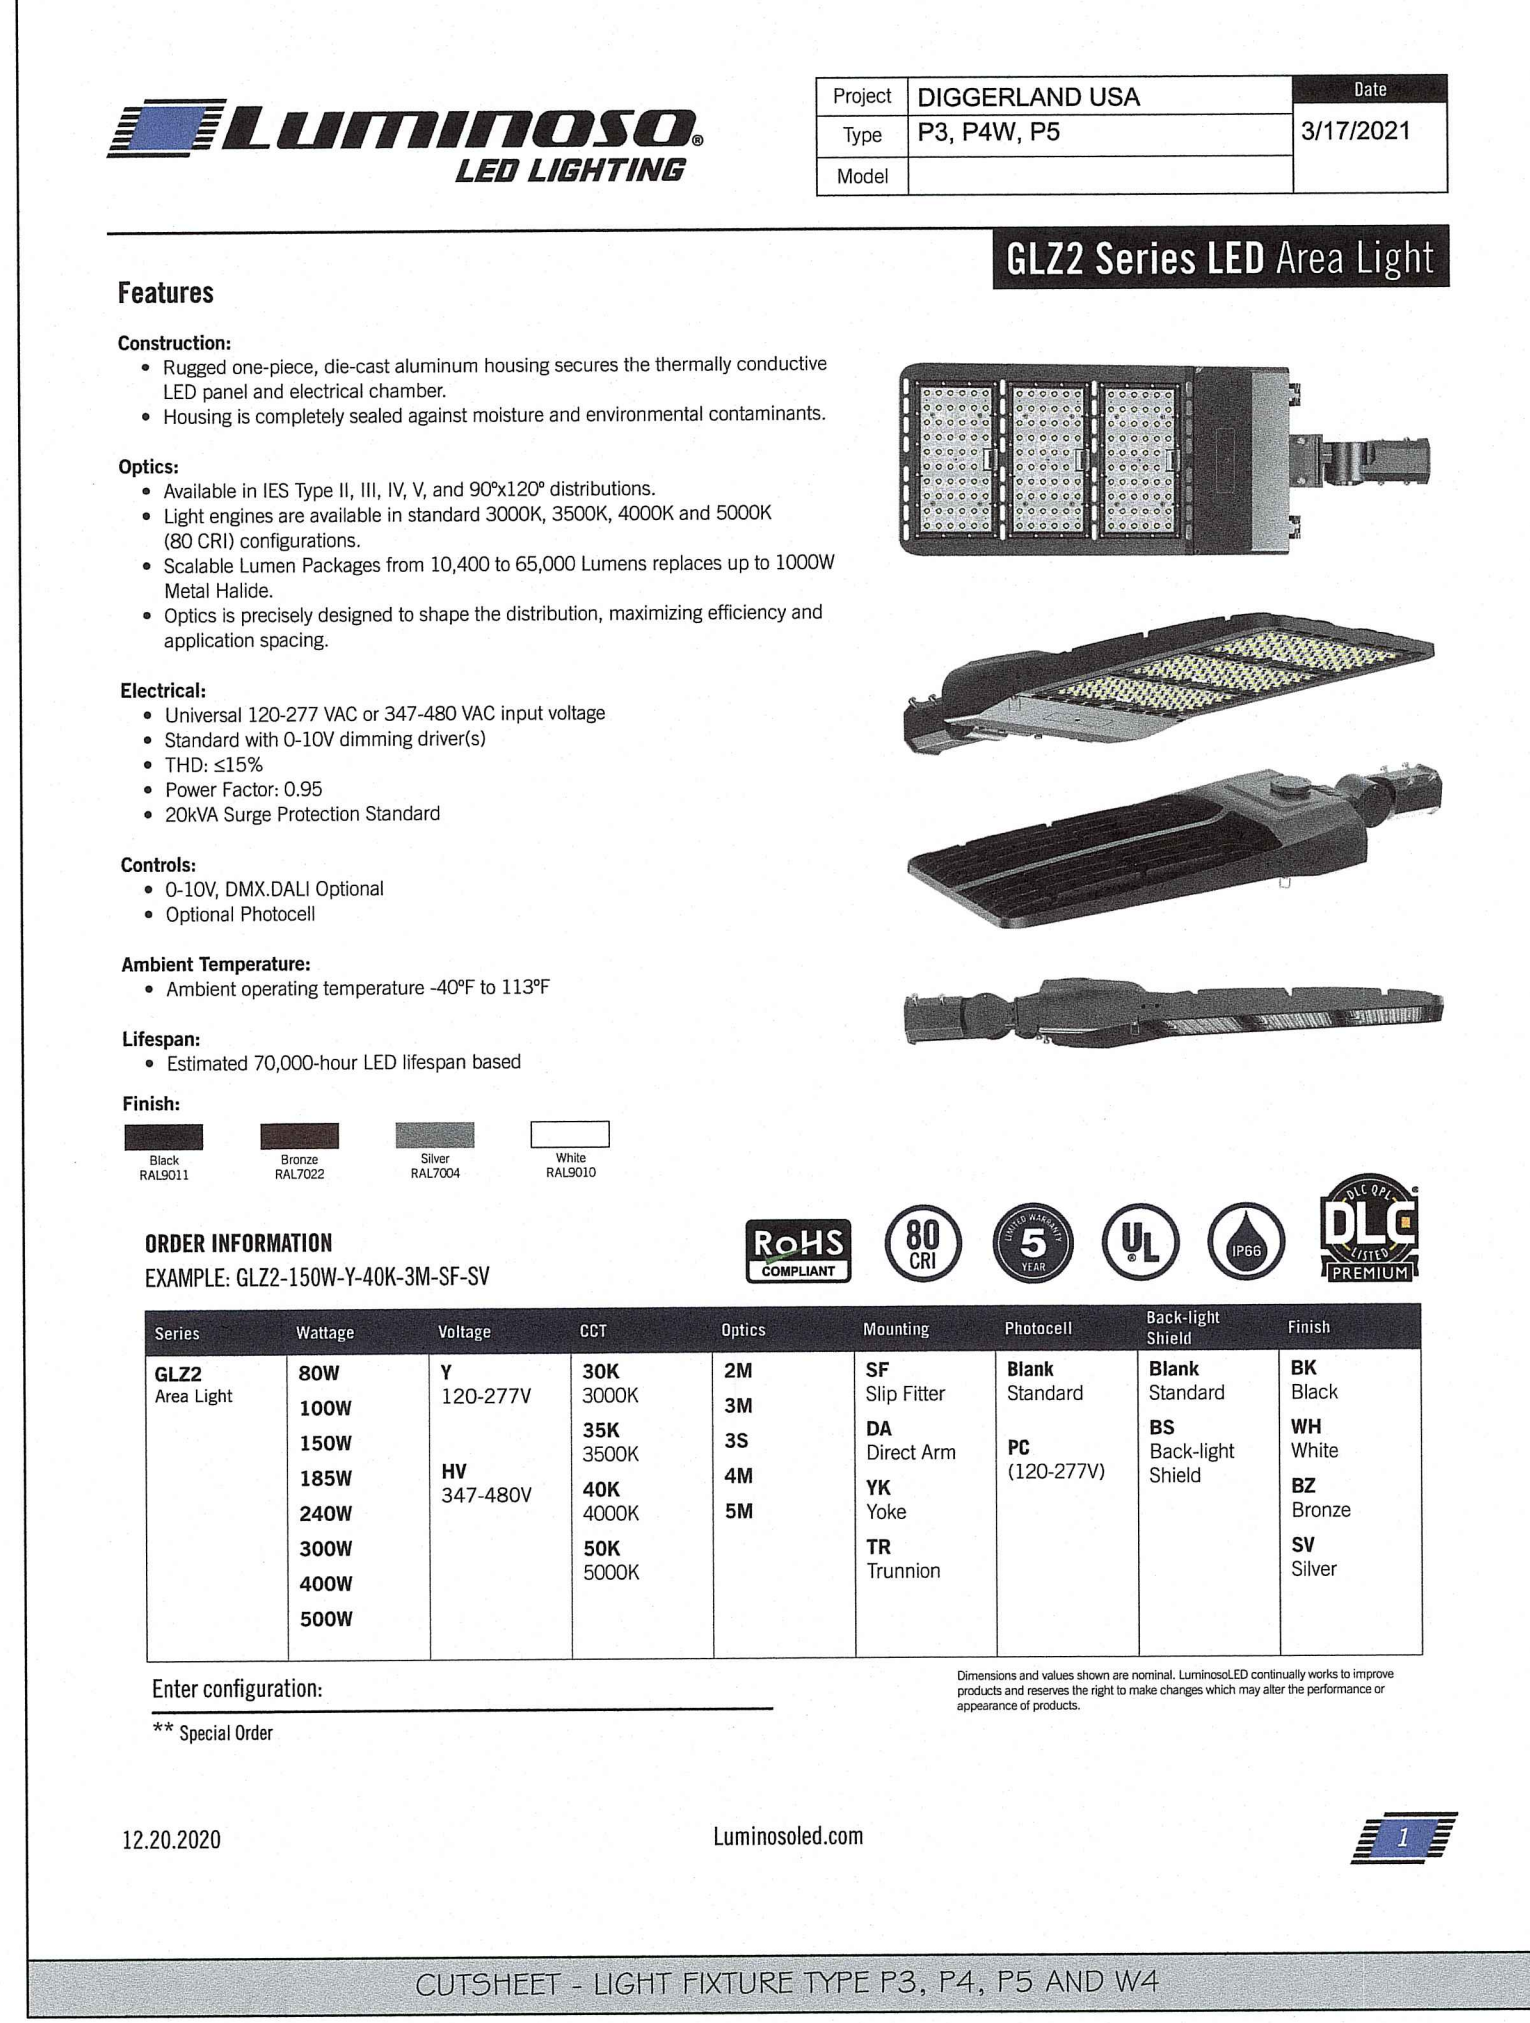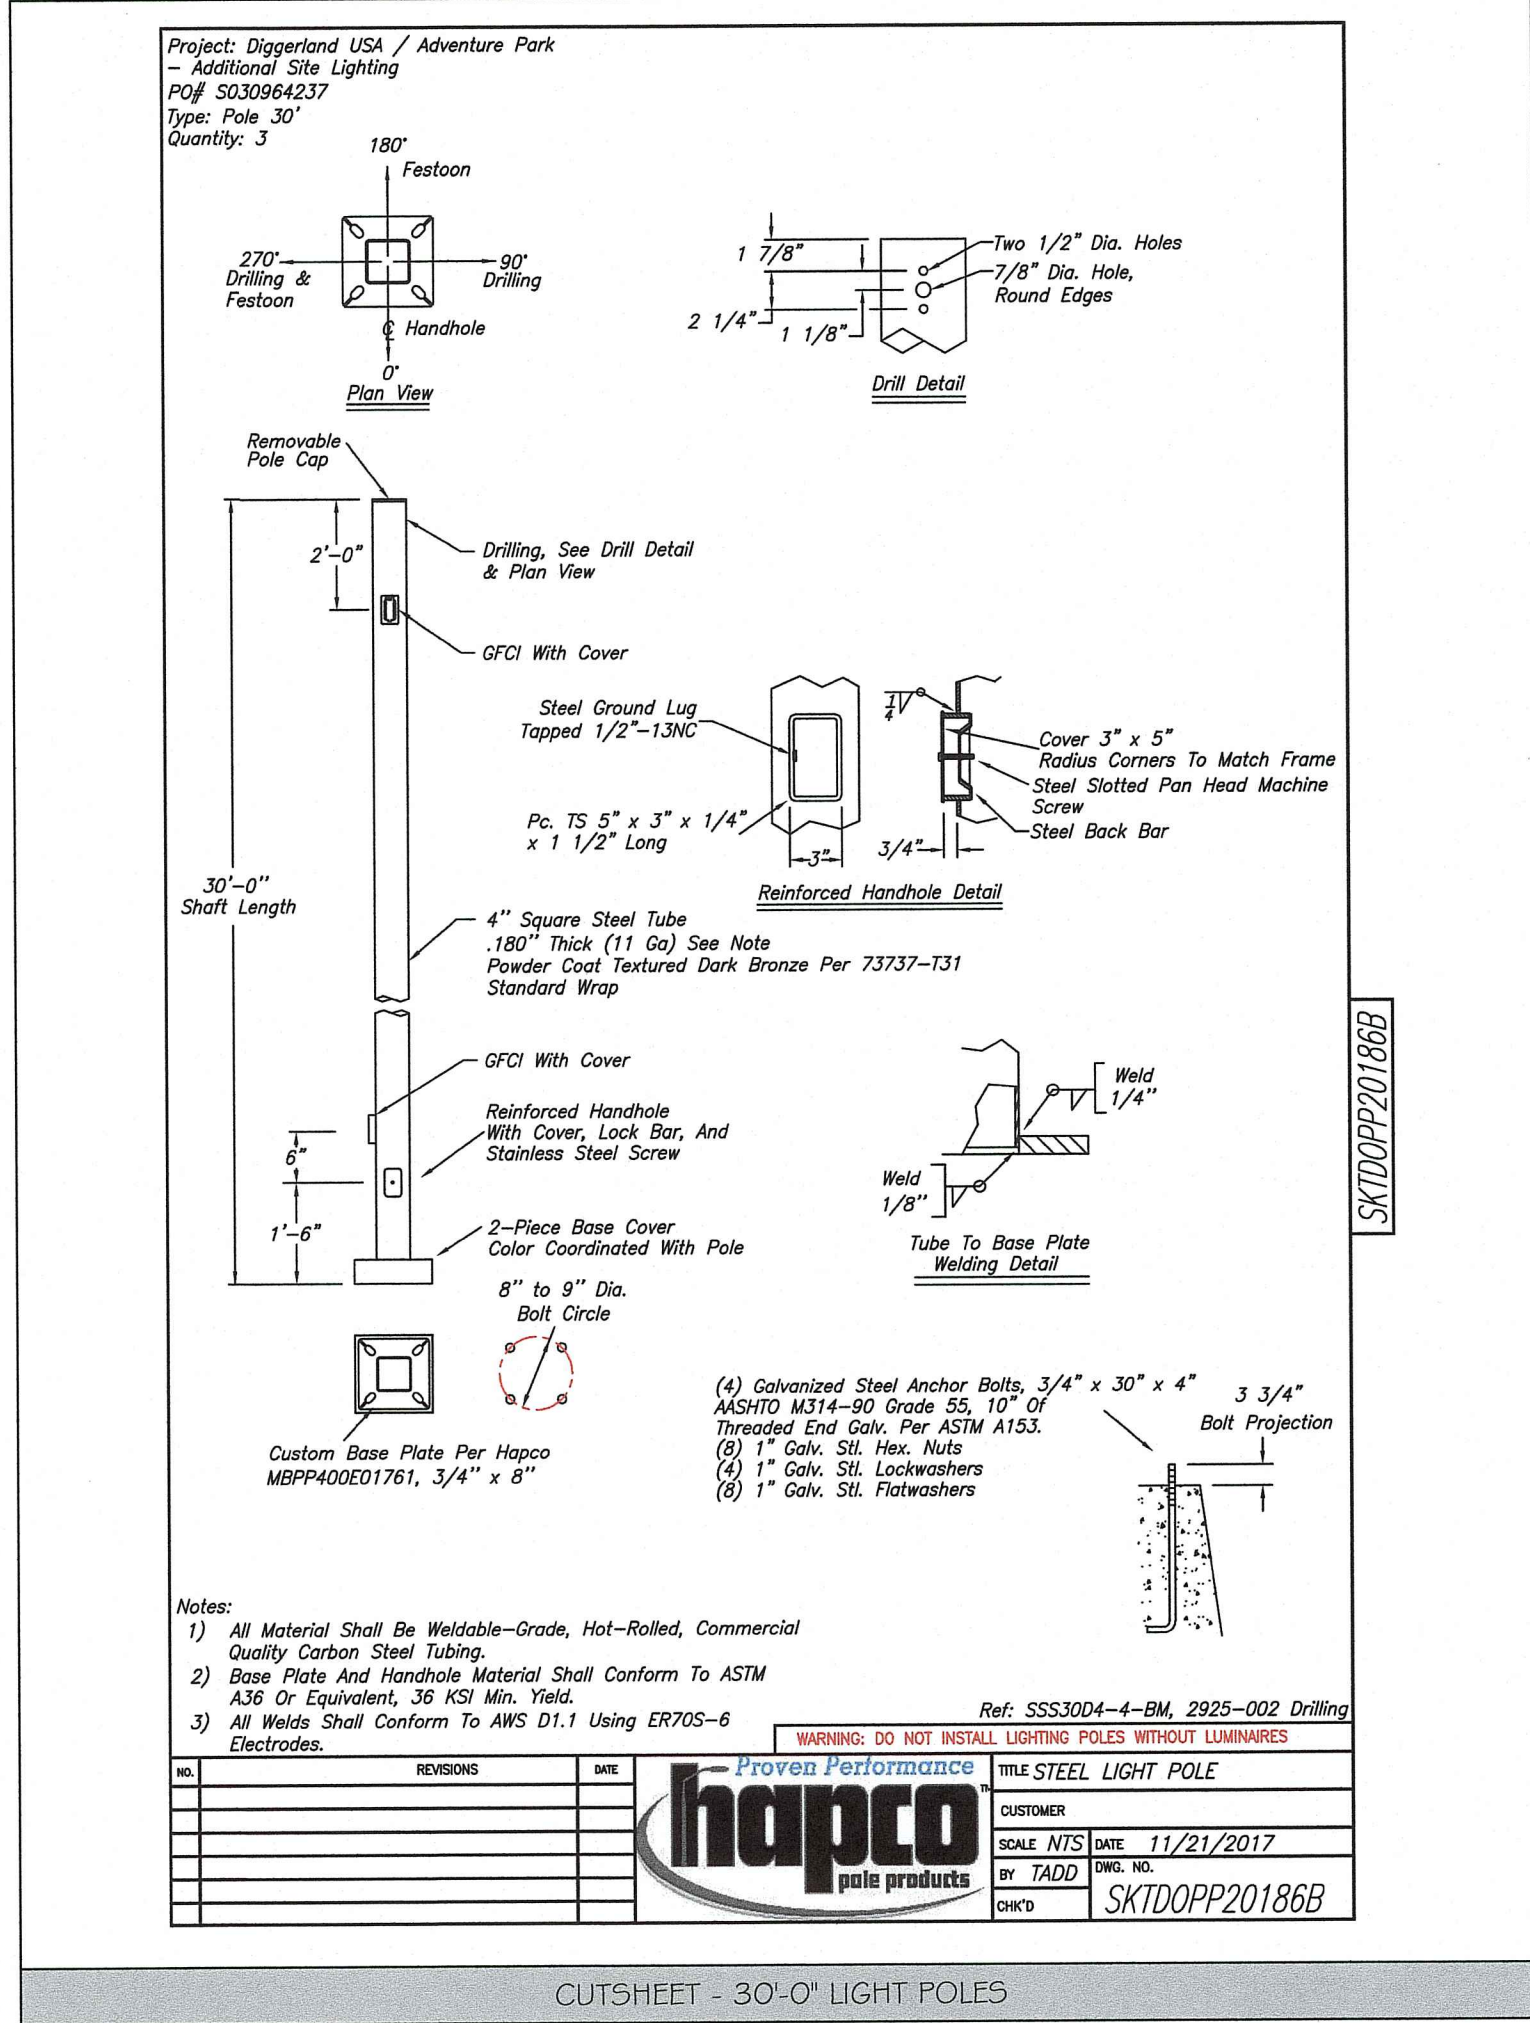

RAMAKER
employee-owned
(608) 643-4100 www.ramaker.com

DIGGERLAND
Business of Fun for Everyone
West Berlin, NJ

Certification & Seal:

James E. Ramaker

MARK	DATE	DESCRIPTION
DATE ISSUED:	07/30/2021	
ISSUE PHASE:	REGULATORY SUBMITTAL	
PROJECT TITLE:	DIGGERLAND USA PHASE II EXPANSION	
PROJECT OWNER:	DIGGERLAND USA	
PROJECT LOCATION:	441 EAST FRANKLIN AVE. WEST BERLIN, NJ 08091	
SHEET TITLE:	SITE LIGHTING PHOTOMETRIC DETAILS	
SCALE:	NONE	
PROJECT NUMBER	50726	
SHEET NUMBER	LP2	

This document contains confidential or proprietary information of Ramaker & Associates, Inc. Neither this document nor the information herein is to be reproduced, distributed, used or disclosed either in whole or in part except as authorized by Ramaker and Associates, Inc.